


NOTES:

Equipment schedule on Drawing No 702-03

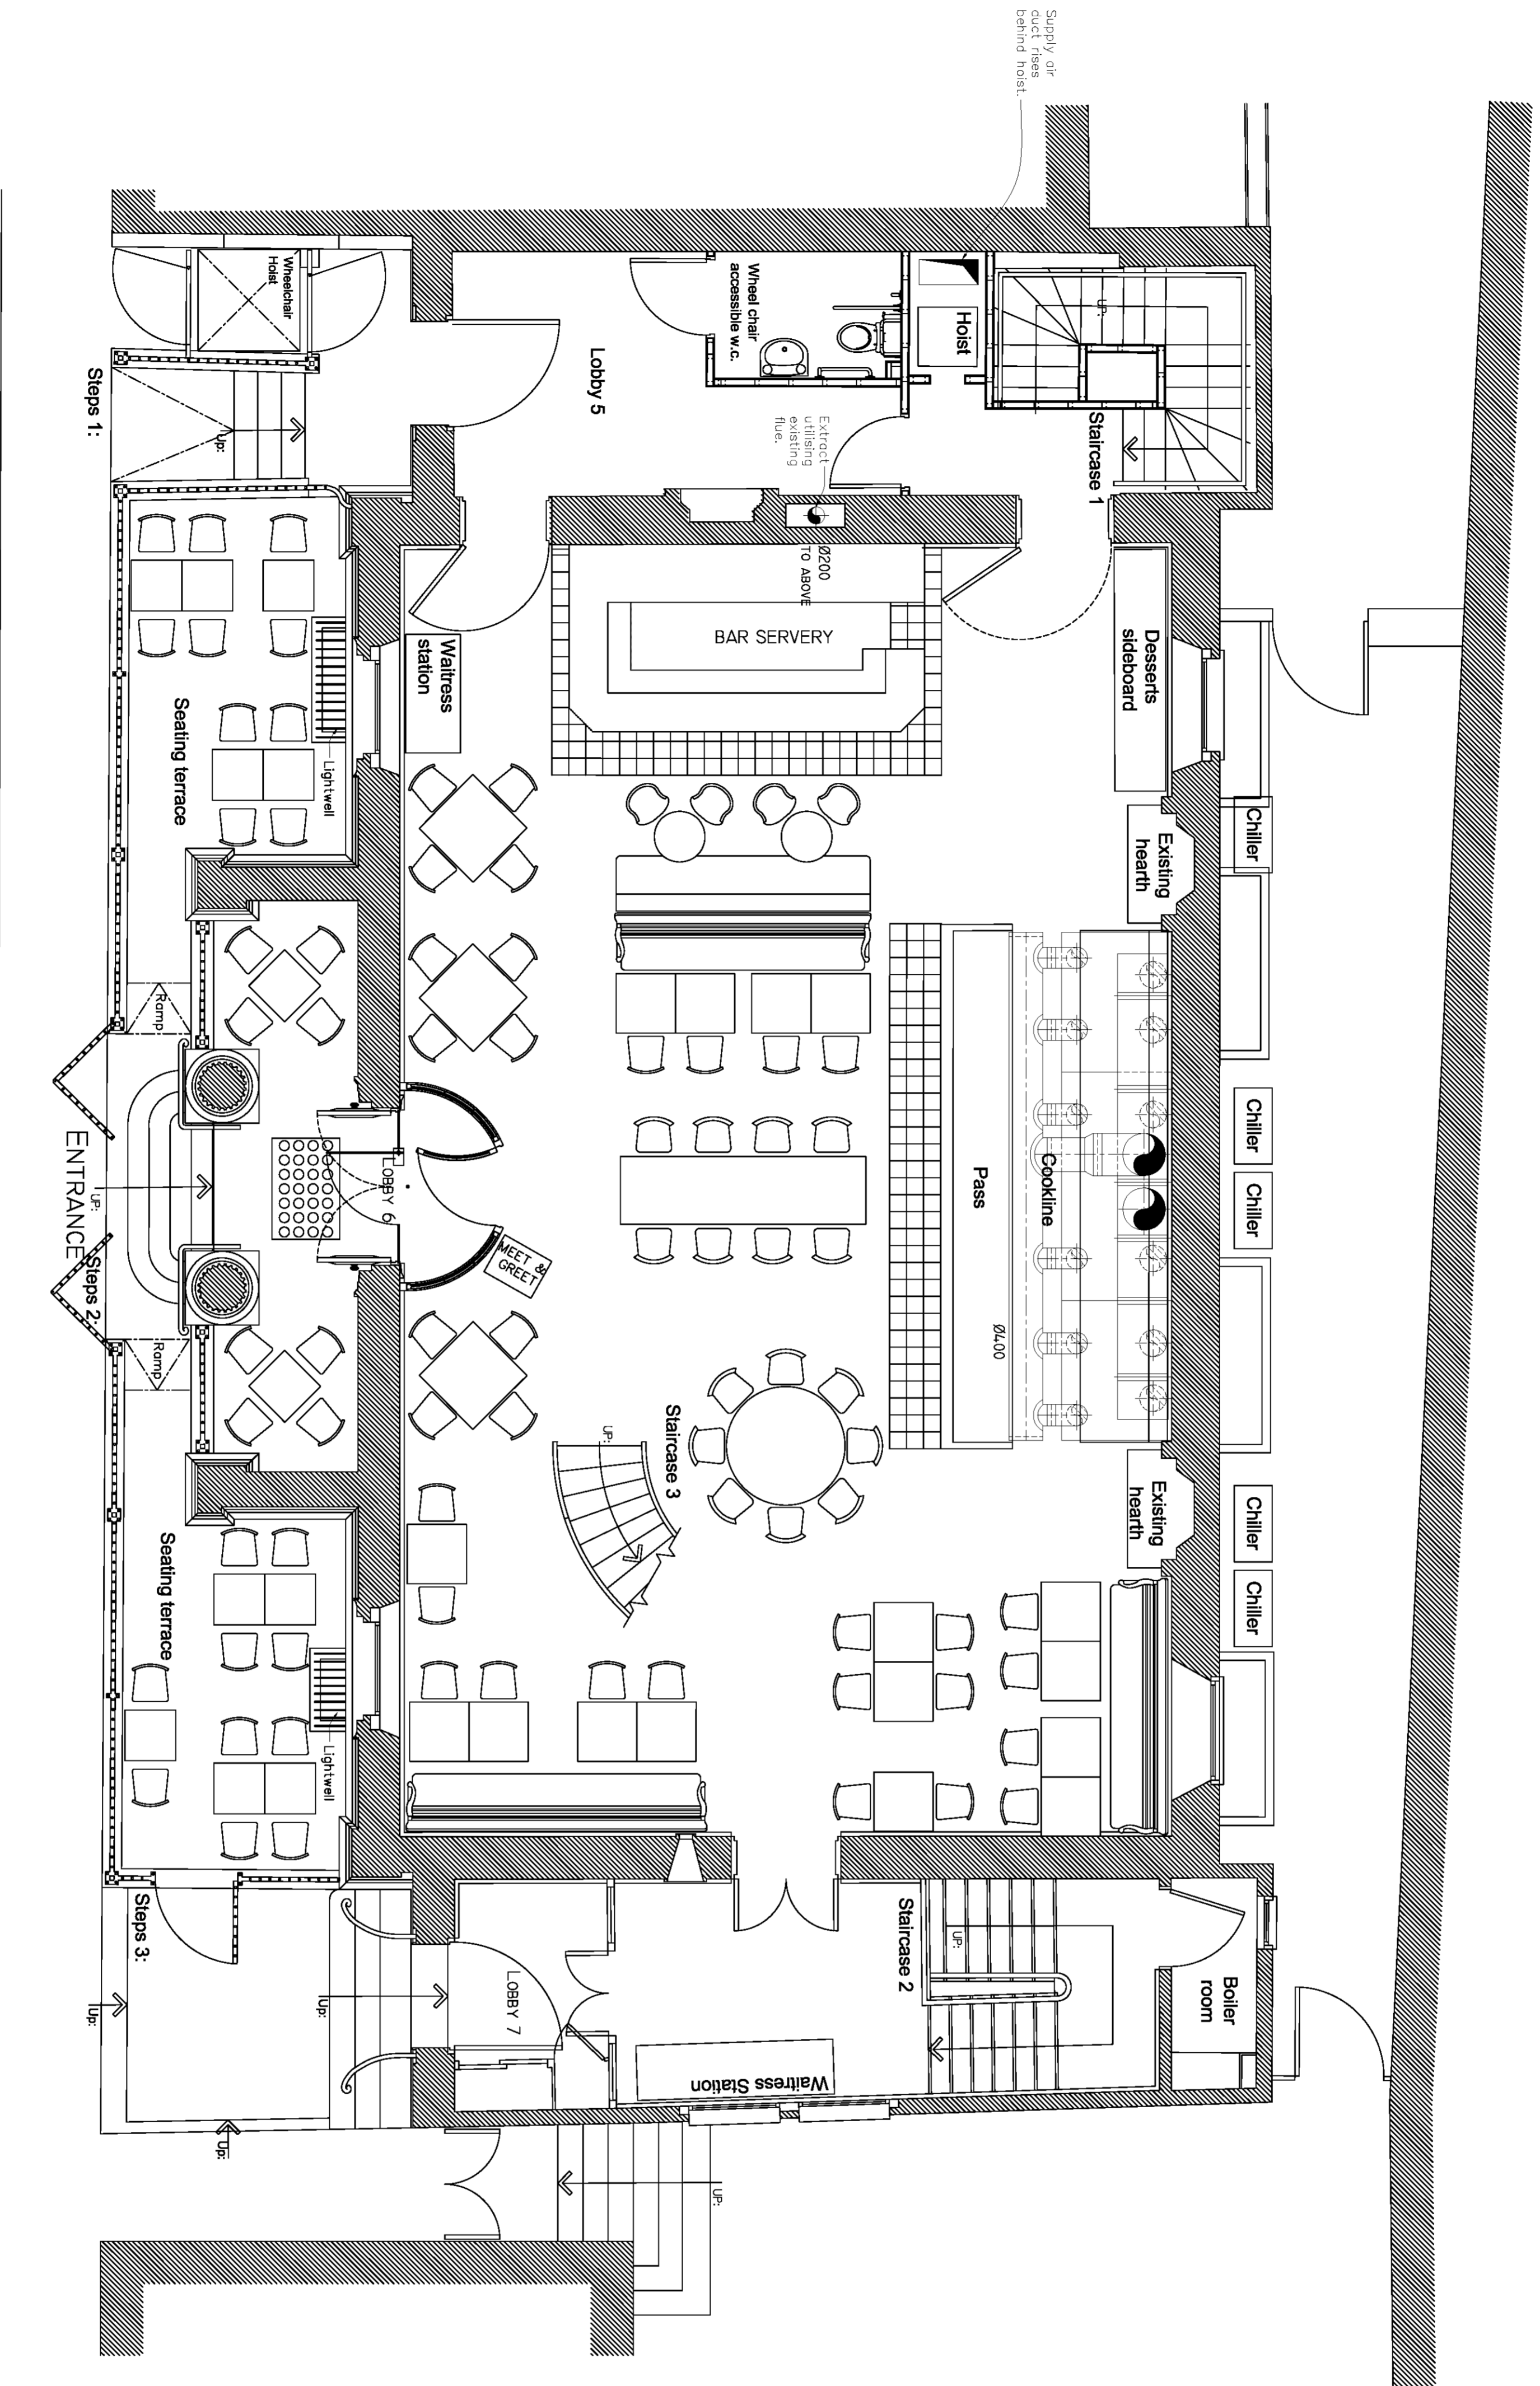

NO.	DATE	REV.	BY	REVISION DESCRIPTION
D	14-11-08	RR		DESSERTS PREP AREA EXTRACT REMOVED, RE-DESIGN TO ACCORD WITH PLANNING REQUIREMENTS
C	24-09-08	RR		REQUIREMENTS
B	11-06-08	RR		ADDITION OF NEW NOTE (SEE NOTES COLUMN)
A	06-05-08	RR		EXTRACT FAN TO BE EXHAUSTED THROUGH LOUVER BENEATH WHEEL CHAIR ACCESS LIFT.

CLIENT:
BRASSERIE BLANC

PROJECT:
 Brasserie Blanc
 Friends Meeting House
 York Street
 Bath
 Somerset
 BA1 1NG

DRAWING TITLE :
 Ventilation Layout
 Ground Floor

DRAWING NO.:
 702-02

REV.:
 D

SCALE: @A1 = 1:50 @A3 = 1:100

DRAWN BY: FR **DATE:** 15/02/08

chappman
 VENTILATION AND CONTROLS ELECTRICAL

Unit 8 Bridgegate Centre
 Marlford
 Melway Garden City
 Westcotville NL7 1JG Fax: 01707 252001
 Tel: 01707 252000
 E-mail: info@chappmanventilation.co.uk
 Web: www.chappmanventilation.co.uk

Copyright of this drawing resides with Chappman Ventilation Limited